

LIST OF ACCOMPANYING DRGS	
A-14021	Plans & Details
A-1972	Std. Specif. Sheet Metal Work
A-424	Std. Tel. Operators Table
A-3828	Std. Conc. Cap. & Clean Out Door
A-3921	Std. Floor Drain
A-1396	Privy


Face Brick Furnished By Wisconsin Lime & Cement Co. Style - West Salem, Dark Brown.

NOTES:
 Footings to extend to firm bearing in Natural Earth, any change to be approved by Engineer in charge.
 All Electrical Work to be furnished & installed by Electrical Dept. of I. C. R. R.
 Interlocking Machinery furnished & installed by Signal Dept. of I. C. R. R. Co.
 All Grading Around Outside of Tower To be Done By R.R. Co.

1 of 2
 I.C.R.R.
 ASHKUM, ILLINOIS
 INTERLOCKING TOWERS
 ELEVATIONS & SECTION
 SCALE: 1/4" = 1'-0"
 MAY 16TH 1923
 CORRECT APPROVED


Revised As Built - 2-24-24 A.I.D.
 Revised - 7-28-23 H.L.
 Revised - 6-18-23 H.L.

ENGINEER OF BUILDINGS CHIEF ENGINEER
 DRAWING NO. A-14020 FILE NO. 6-19
 Drawn By: H. J. S.
 Traced: H. J. S.
 Checked: H. J. S.

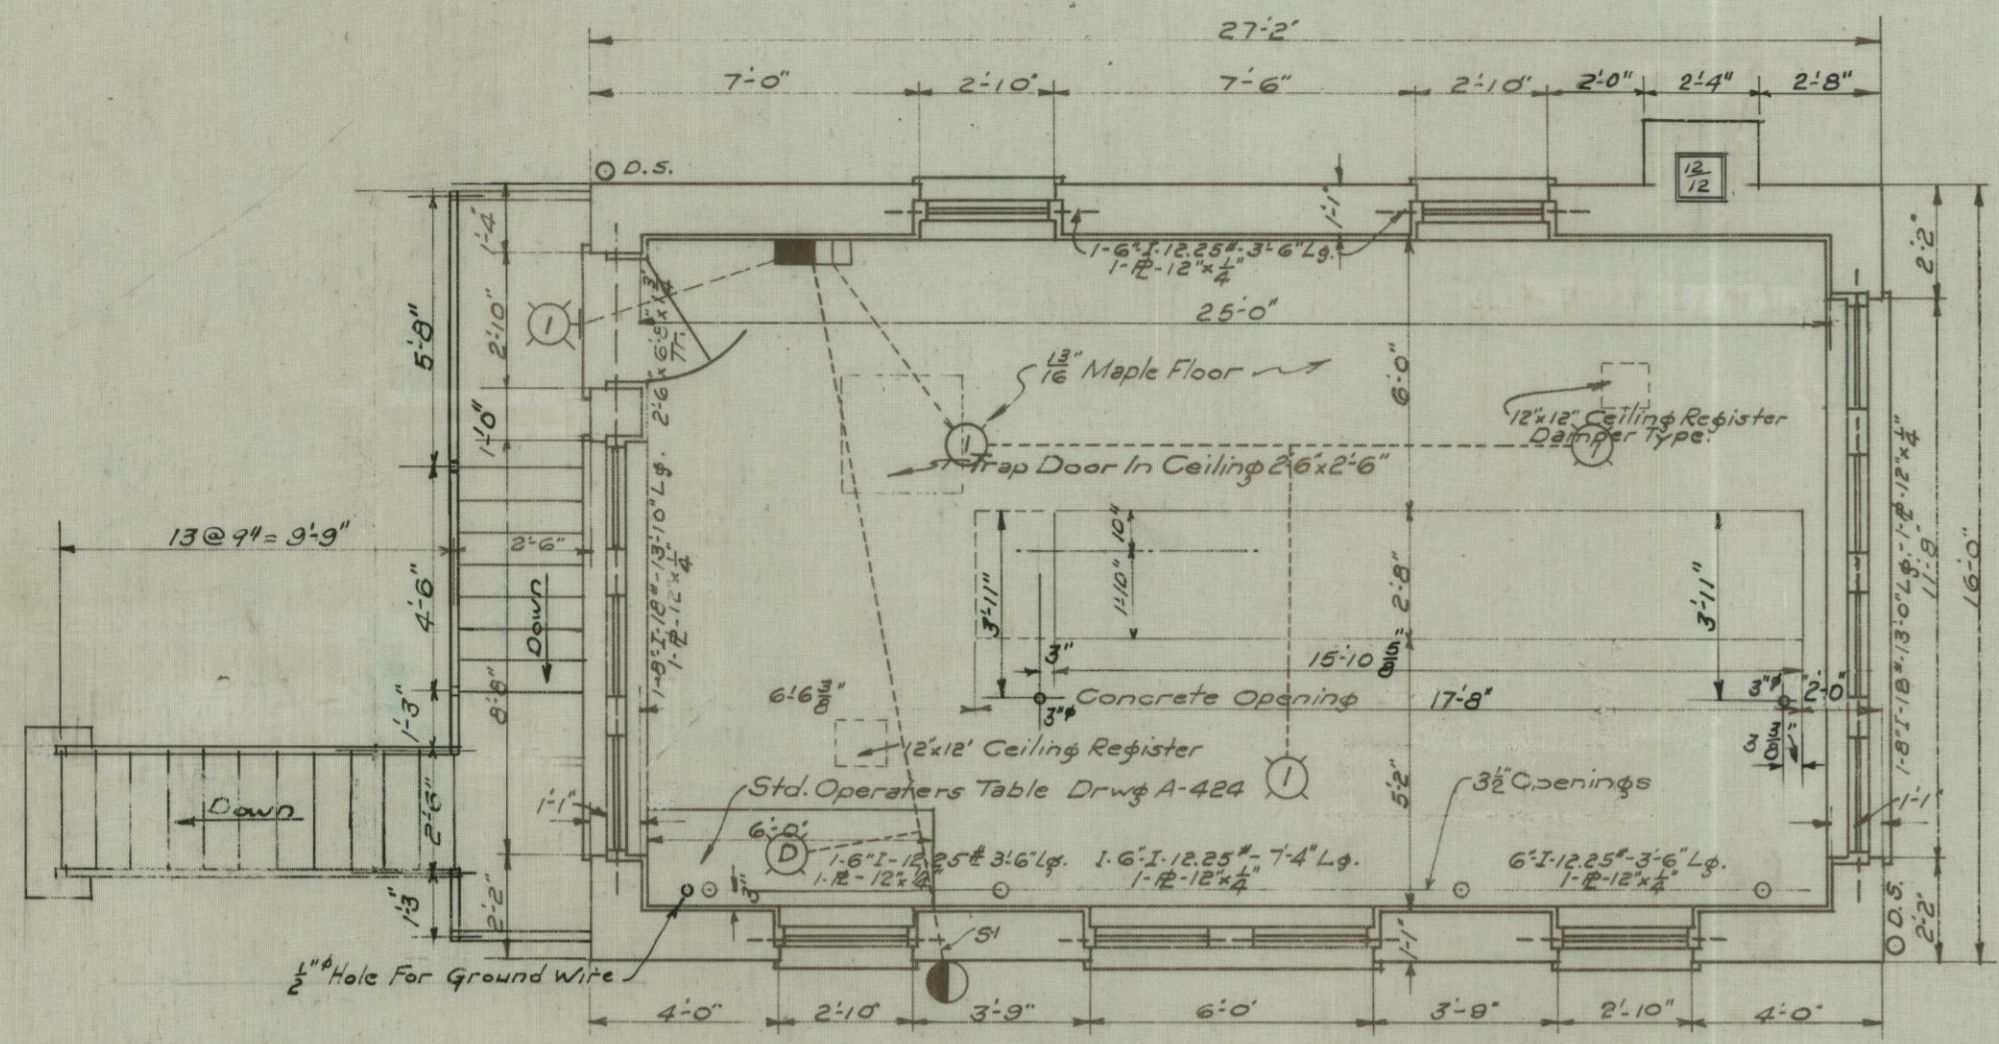


SECOND FLOOR PLAN

Note: Leave openings in all floors for heating ducts where directed.

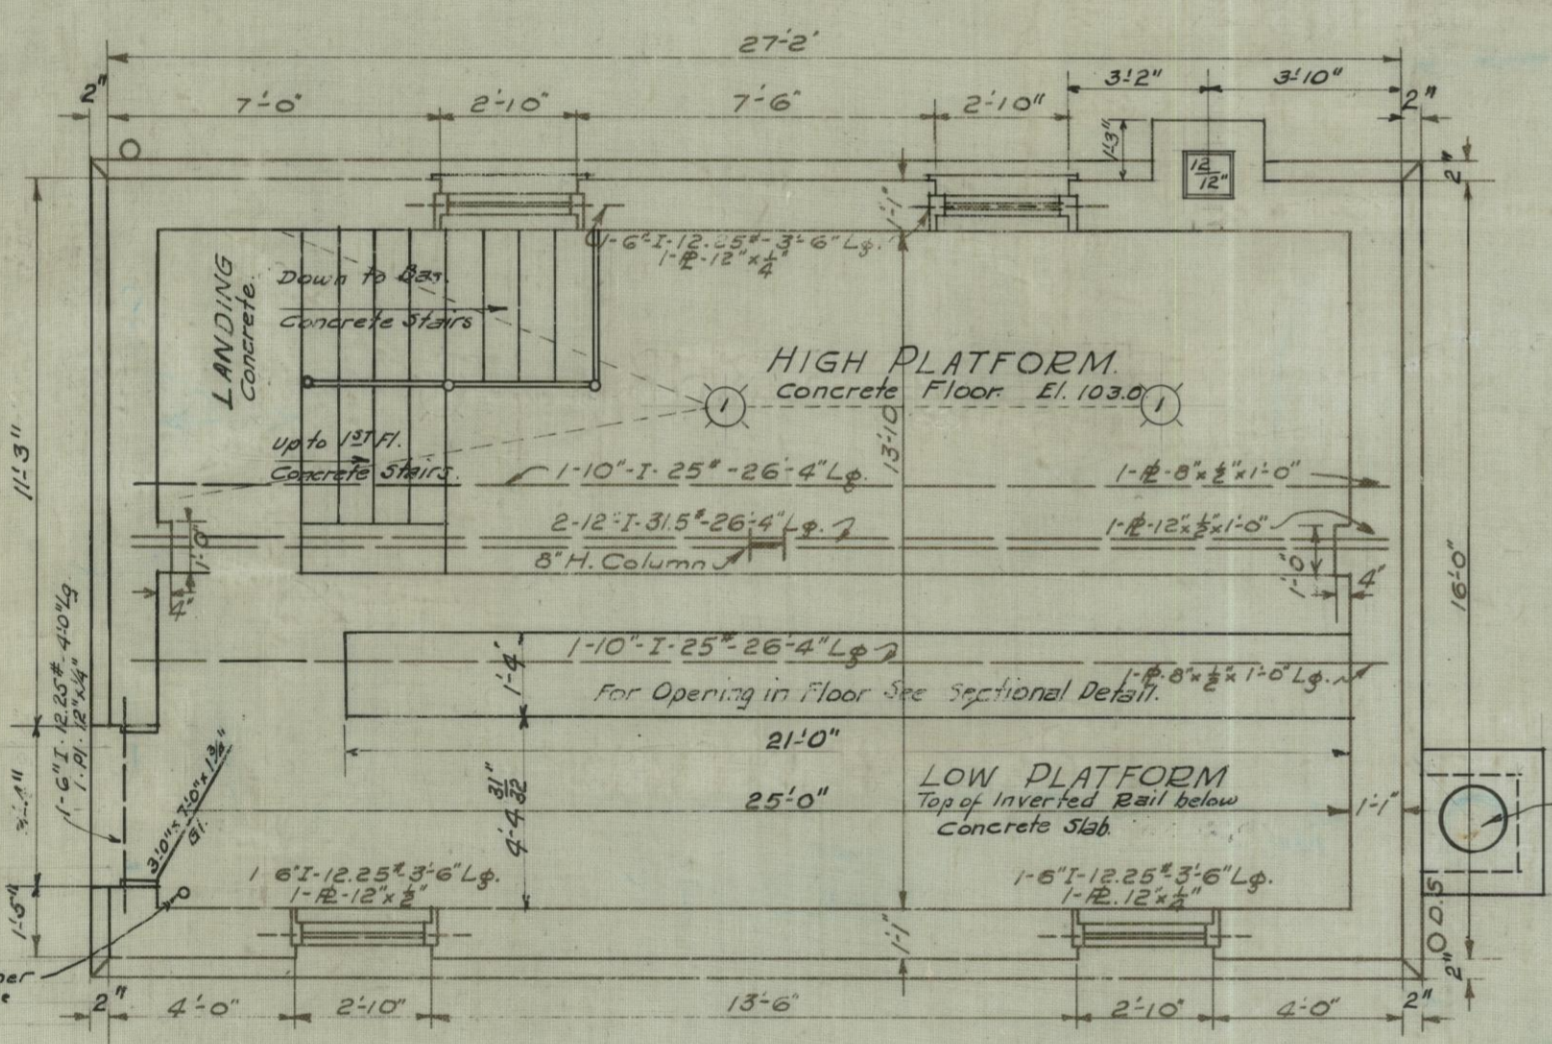


FIRST FLOOR PLAN

1/2" Pipe 1'0" Above Floor Placed in Corner to Act as Stop to Interfere with Door

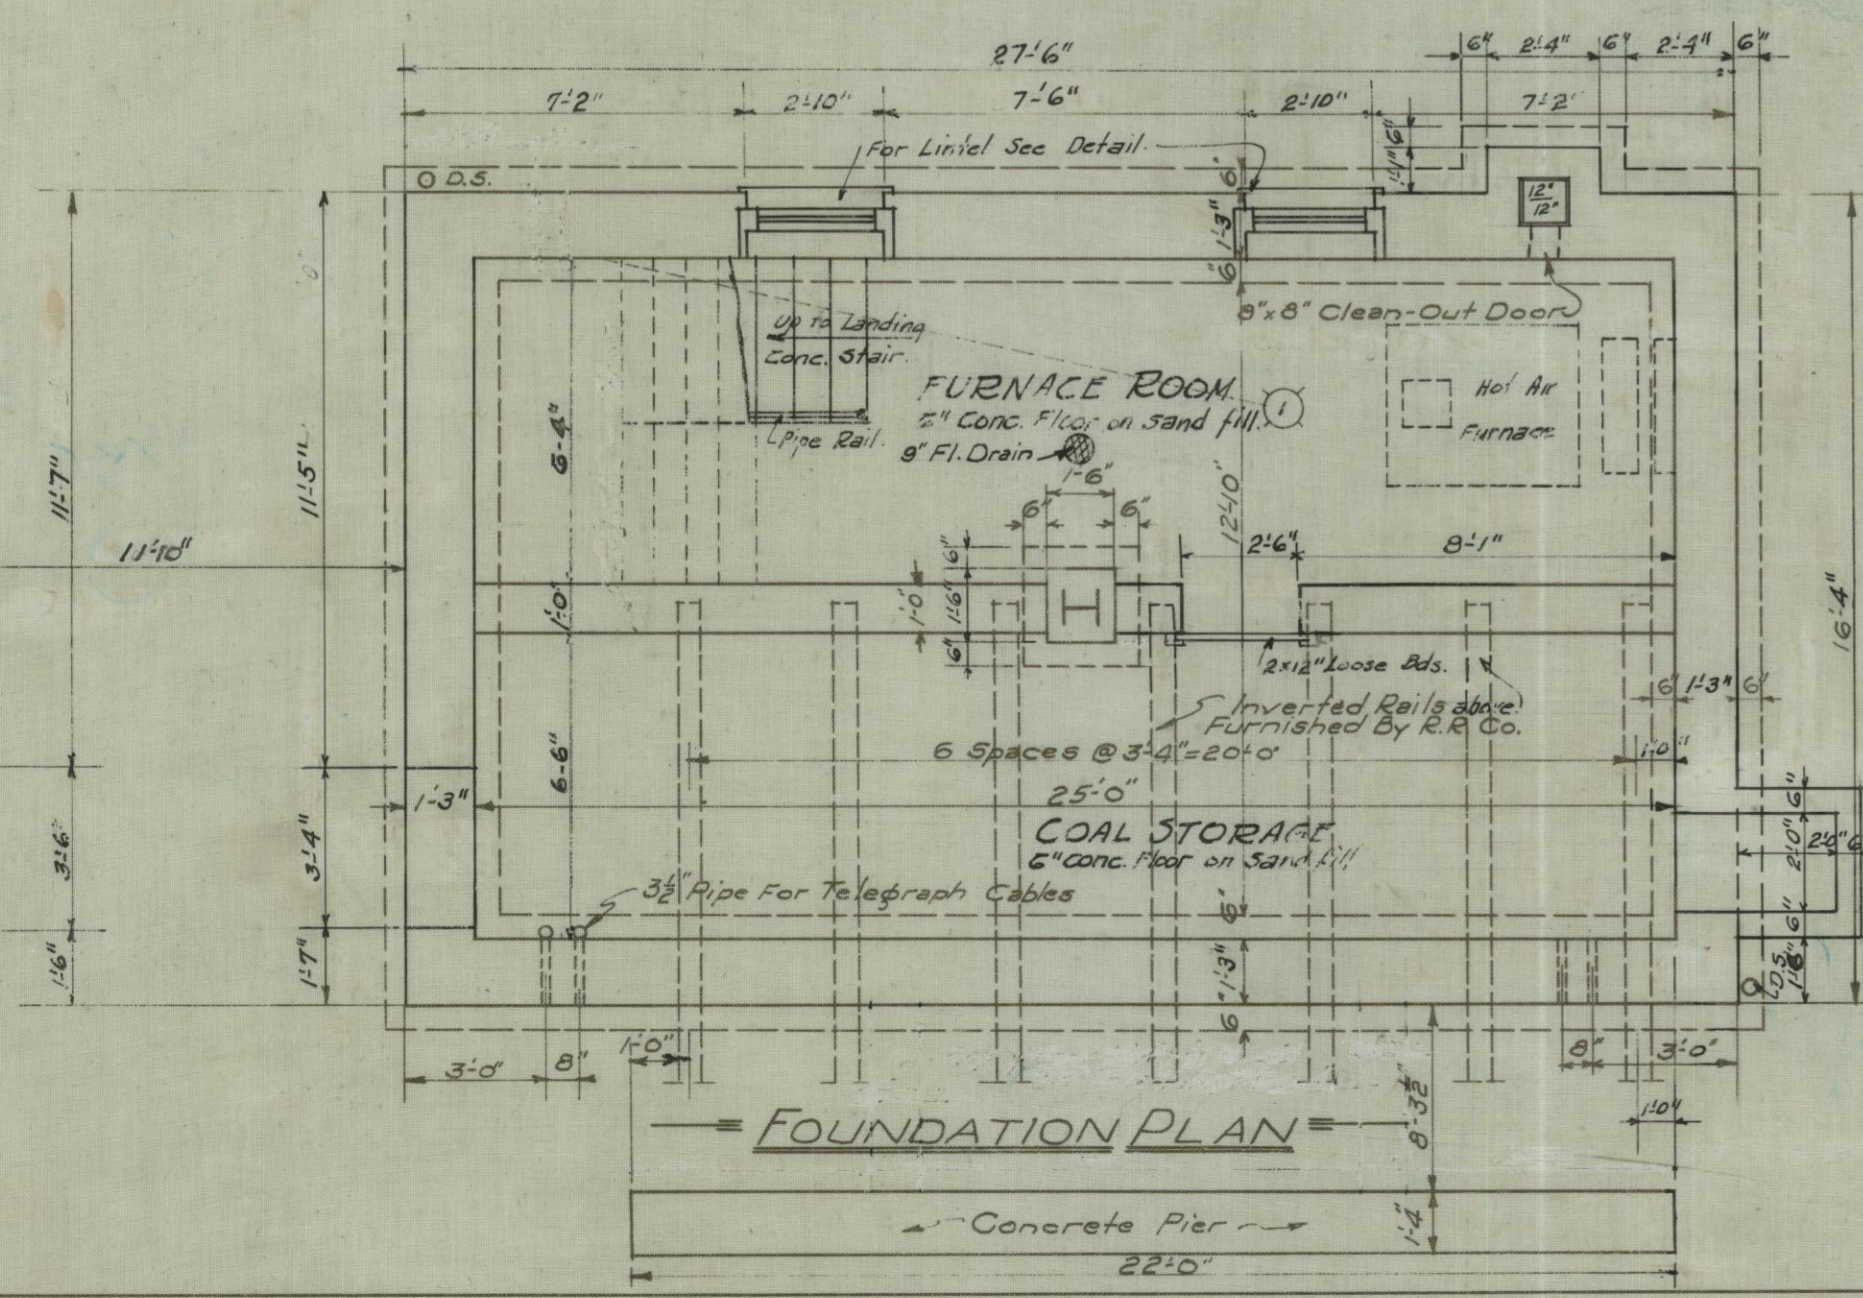

FOUNDATION PLAN

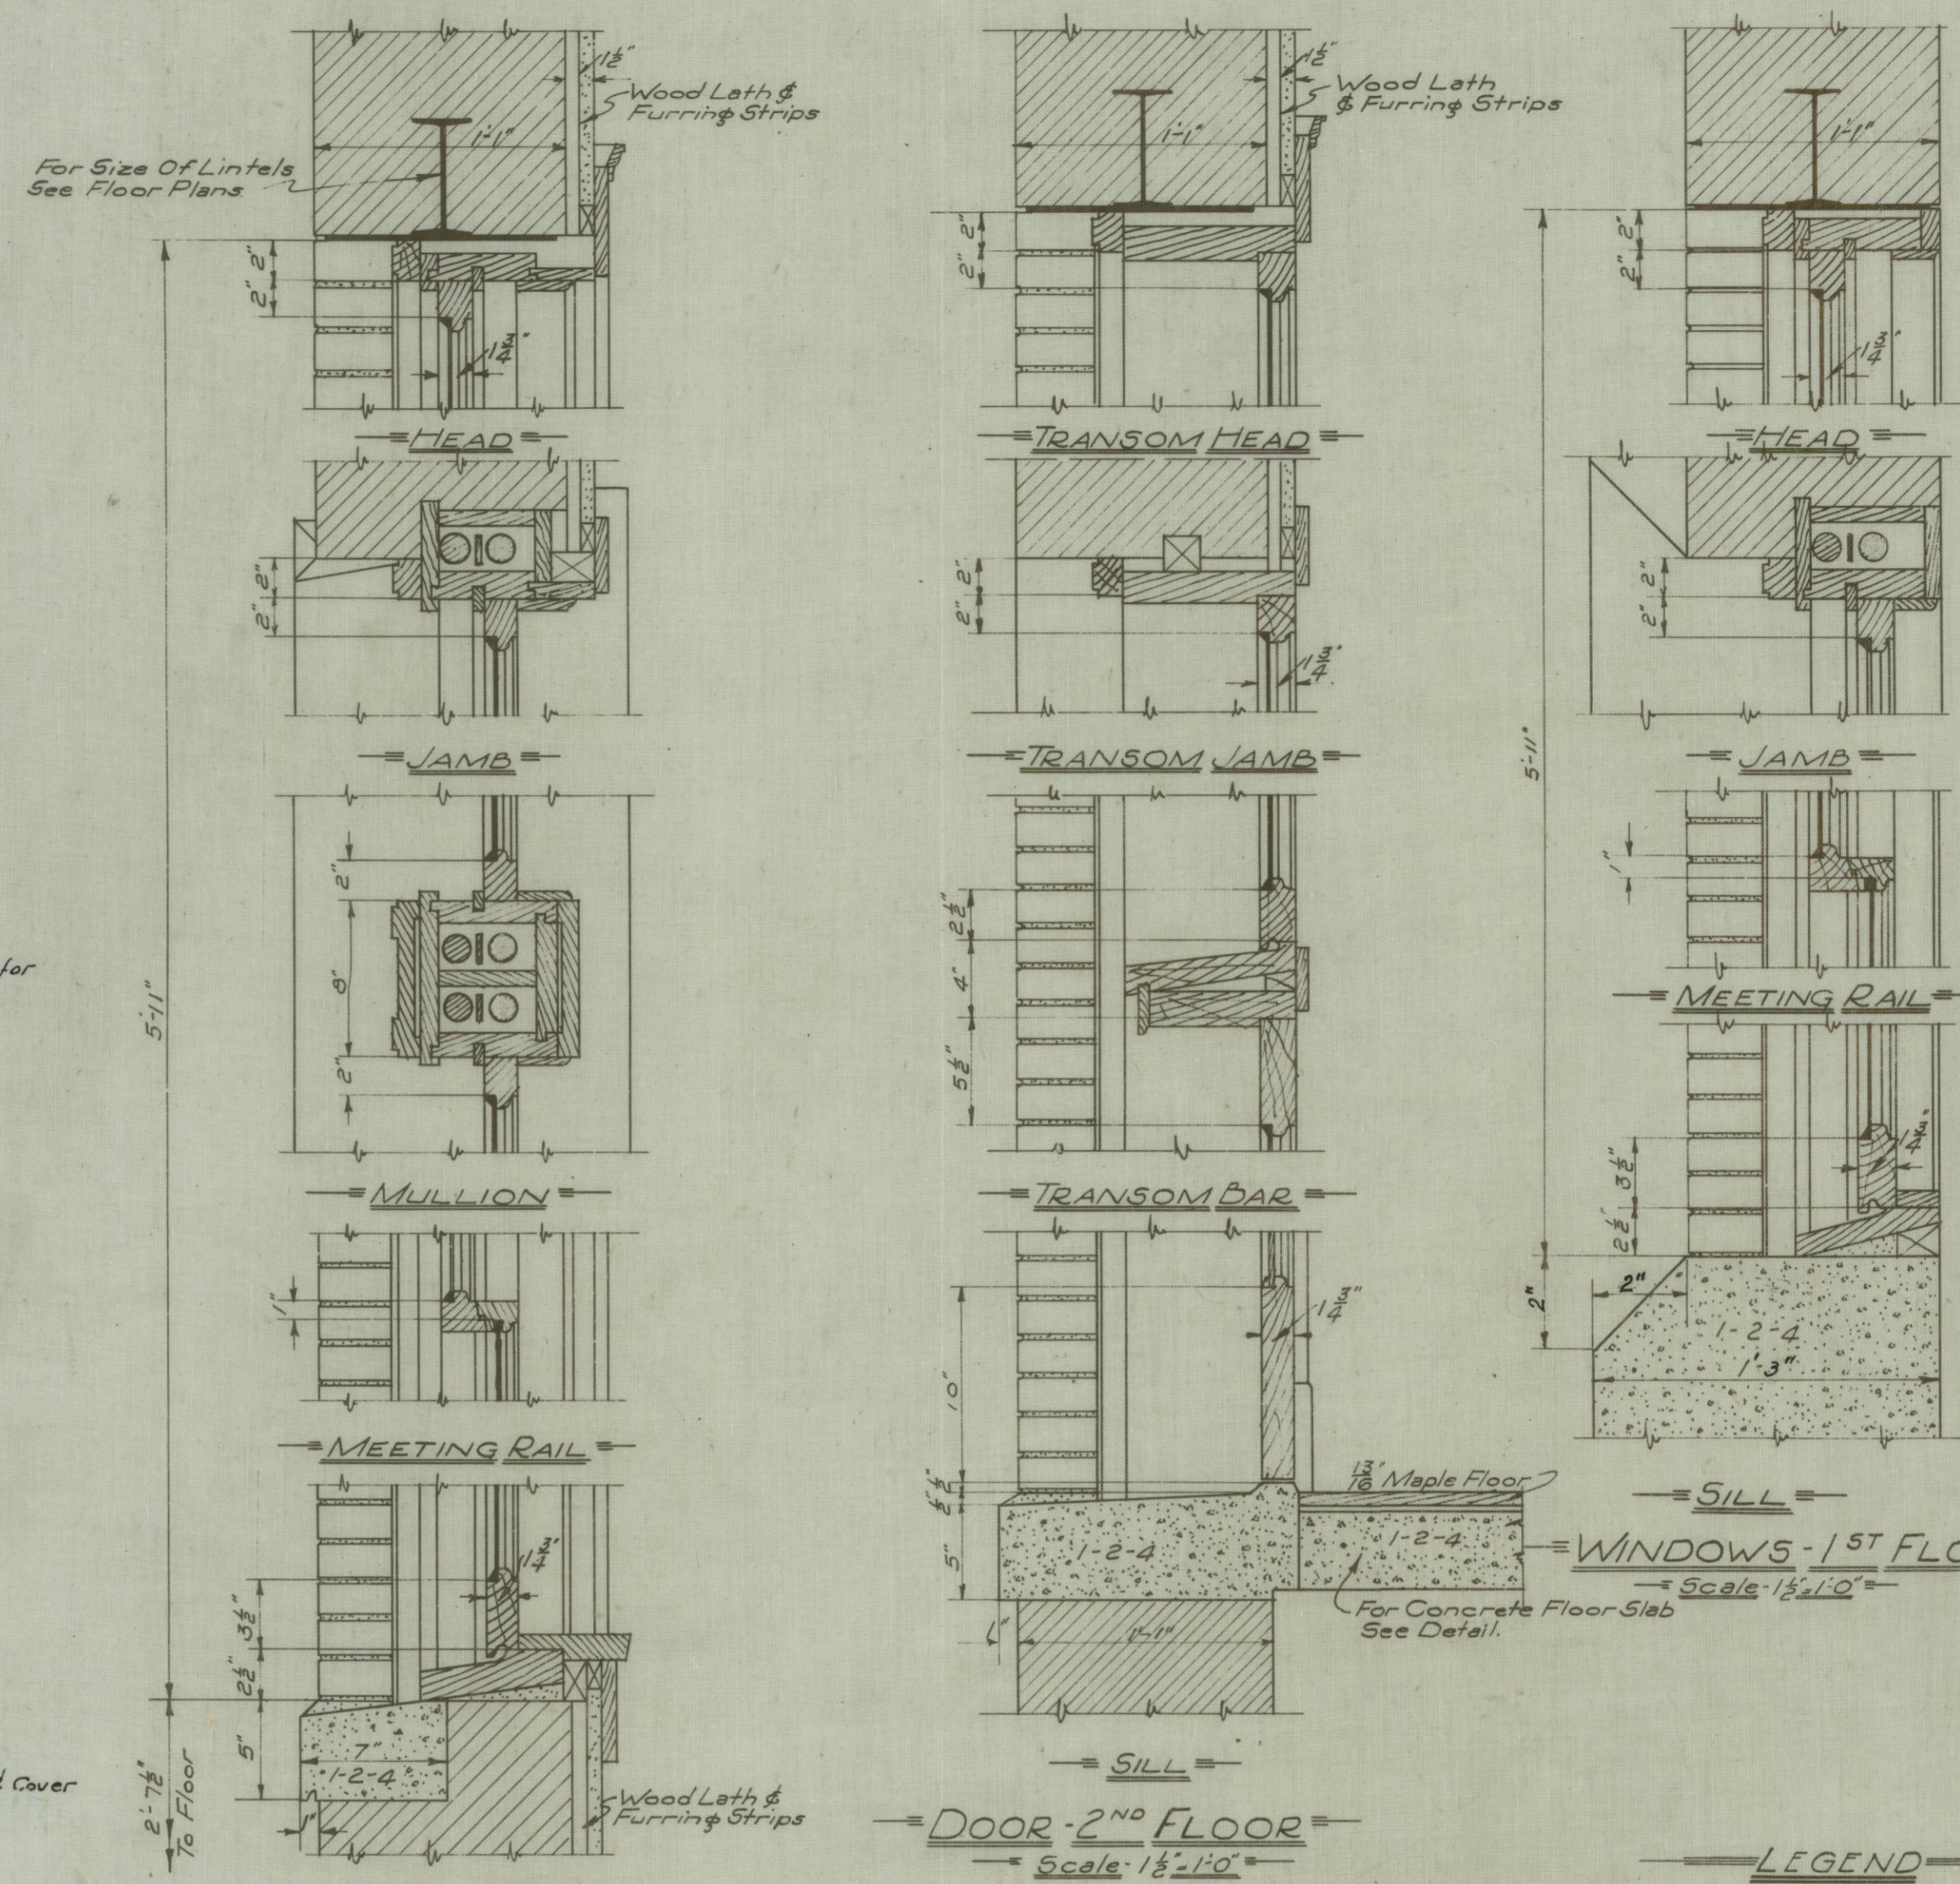

WINDOWS - 2ND FLOOR


DOOR - 2ND FLOOR

WINDOWS - 1ST FLOOR


LEGEND

- Flood Light for Car Numbers.
- 2642 - Harter With Chain Pull Switch.
- ⊙ 420 - Harter Drop Canopy Switch.
- ⊕ Bracket Over Door.
- Meter Box.
- Distribution Box.
- S-1 Switches.


Lights over Manipulation Chart to be located after Board is set and Chart is up.

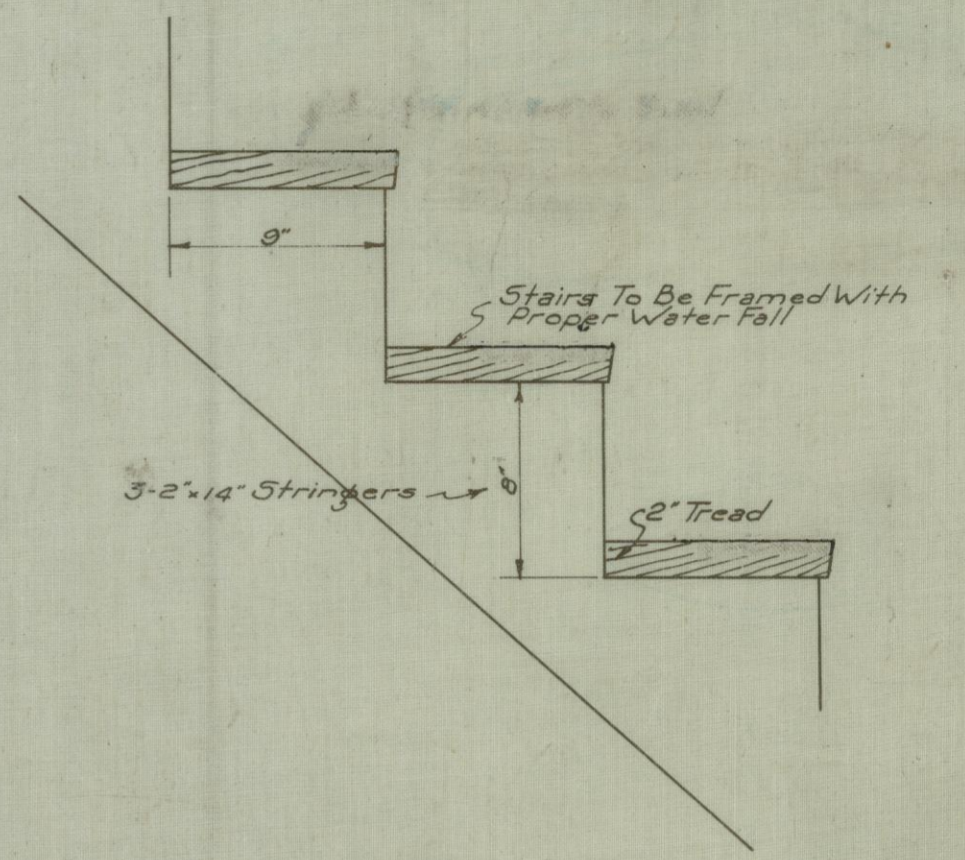


DETAIL OF STAIRS

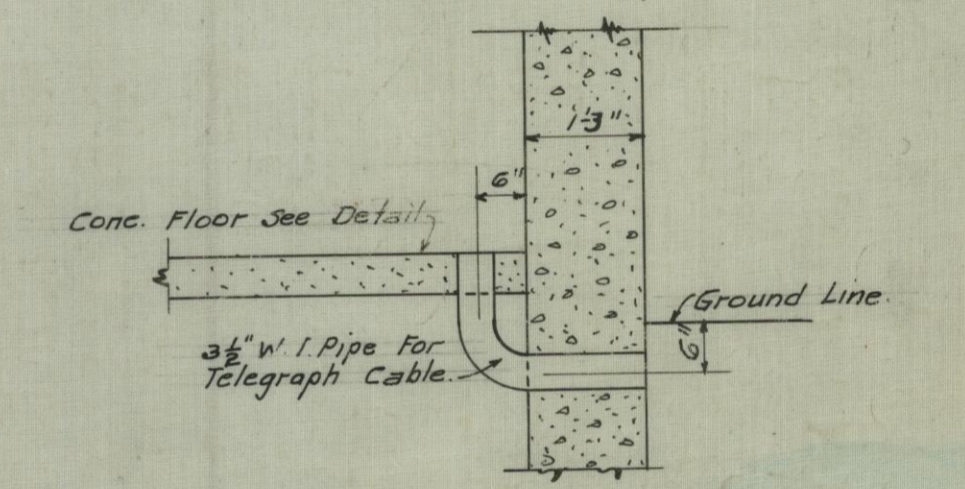

DETAIL OF CABLE OPENINGS

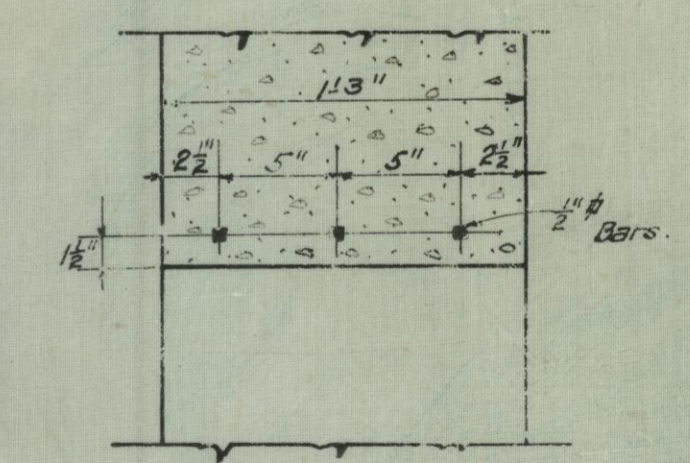

LINTEL FOR WINDOWS IN BASEMENT

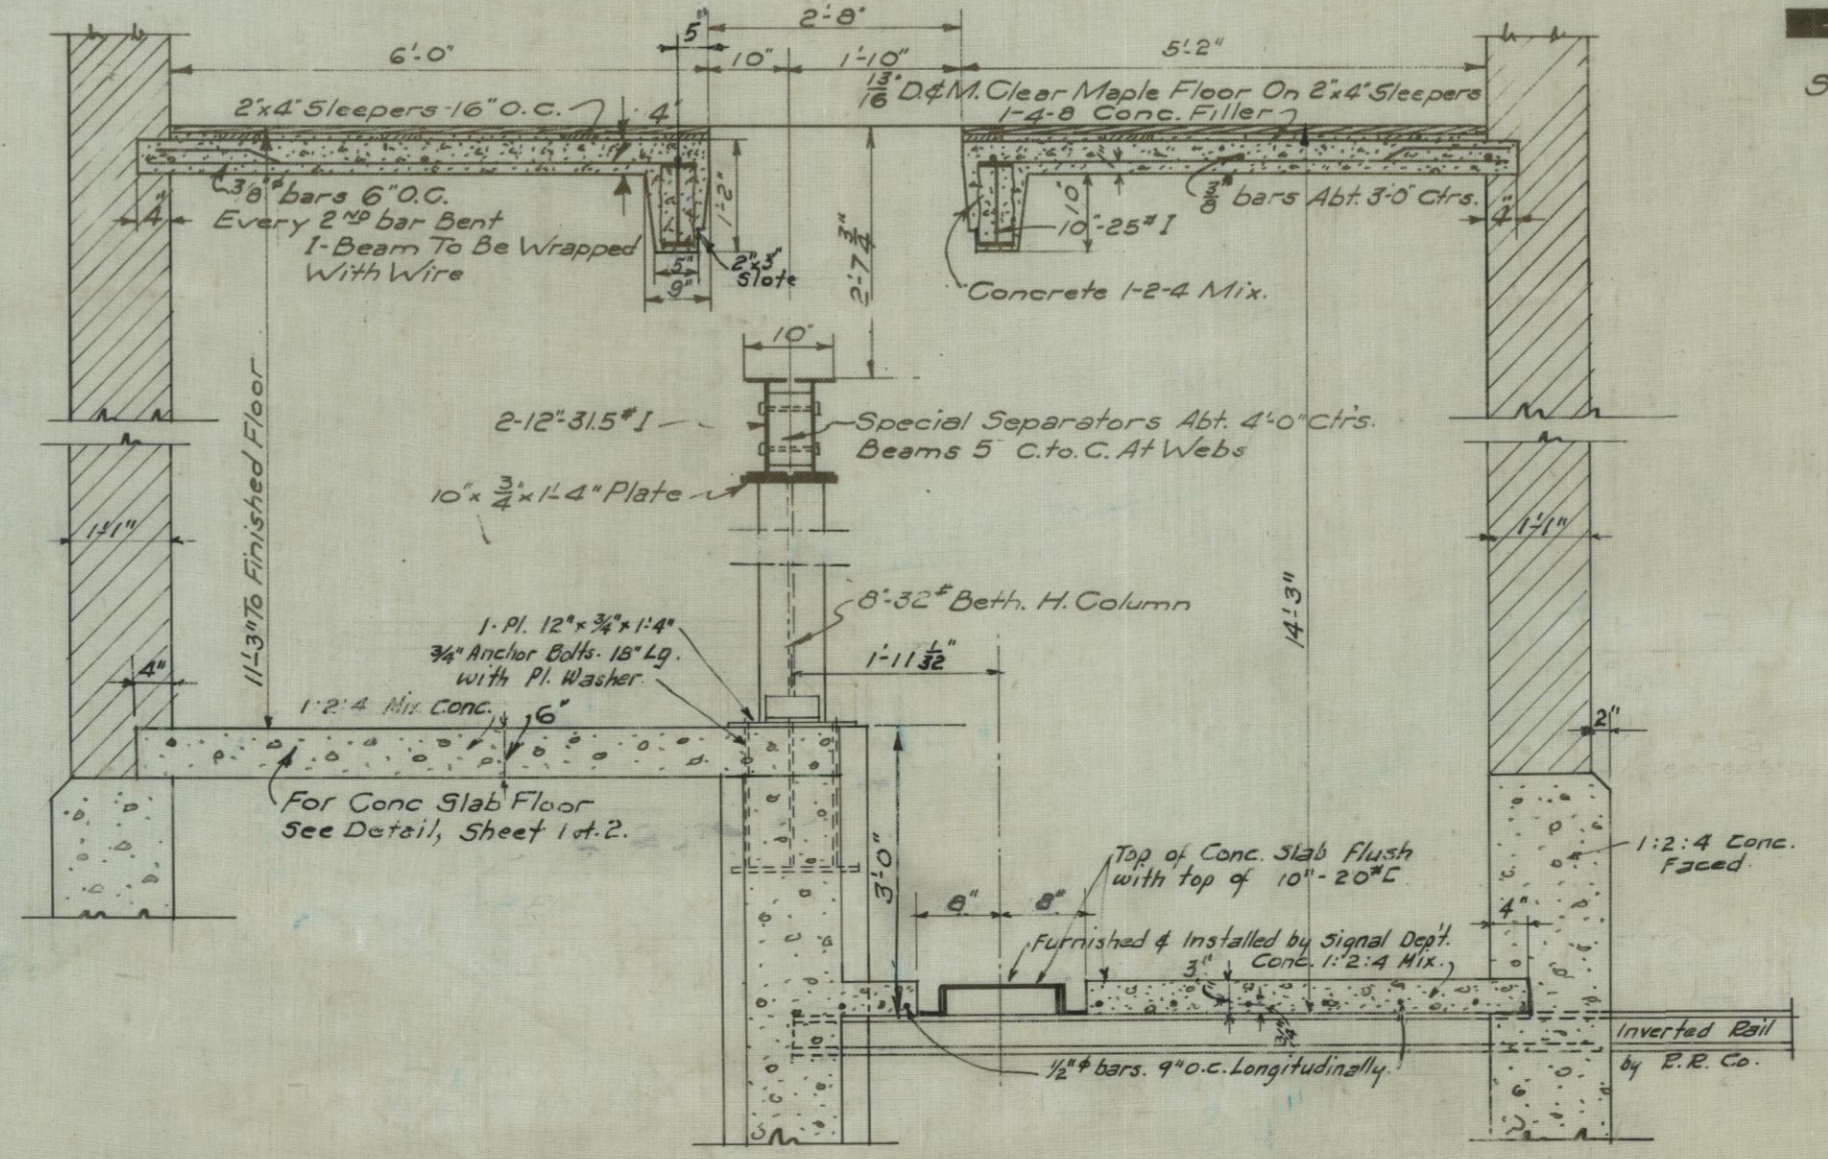

DETAIL OF FLOOR & MACHINE SUPPORT

I.C.R.R.
ASHKUM, ILLINOIS
INTERLOCKING TOWERS
PLANS AND DETAILS

SCALE: 1/8" = 1'-0"
MAY 16TH 1923

ENGINEER OF BUILDINGS CHIEF ENGINEER
DRAWING NO. A-14021 FILE NO. 6-20
DRAWN BY H.L. J.S.
TRACED BY C.M.C.
CHECKED BY H.L.

Revised - 6/16-23 - H.L.